



Paalhouders

INDEX

Specifications	2
Drawings	3
Downloads	8

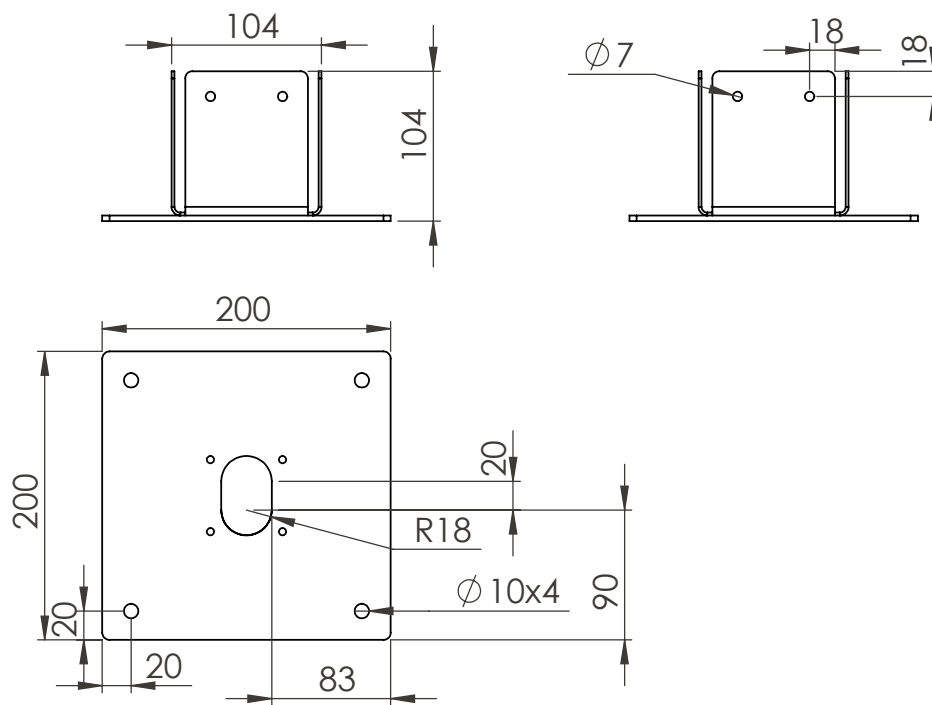

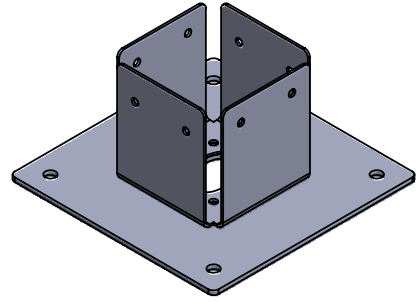

SPECIFICATIONS

Post holder

Models: EYE 100, PERI 100, TORRE 100 en SPINA 100

Weight: 3kg





timberlab

Timberlab B.V. - Harskamperweg 32 - 6731AB Otterlo
The Netherlands T +31 (0)318 943617 -

TITLE: PH02			
FILE: Production drawing		REVISION A 17-1-2025	
Drawn by: DR	Checked by: TvD	MATERIAL: Kastanje	A4

Scale: 1:5

SHEET 1 OF 1

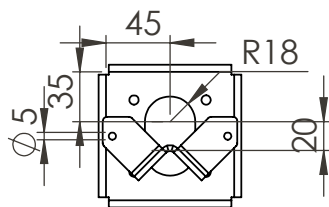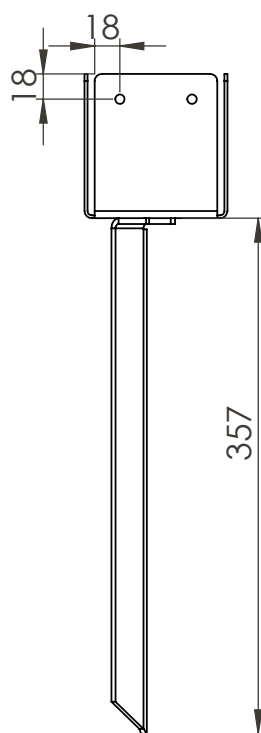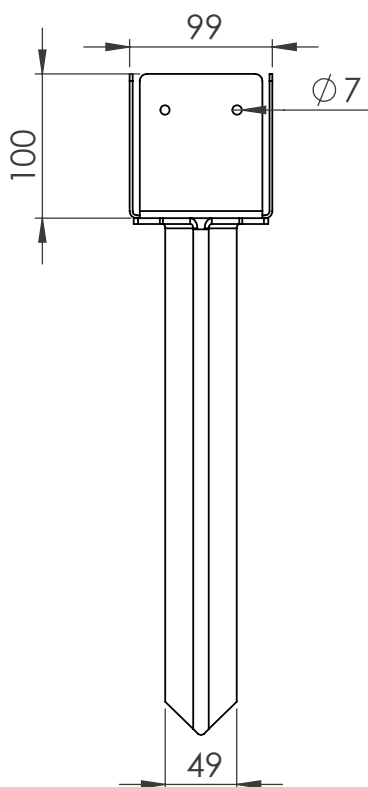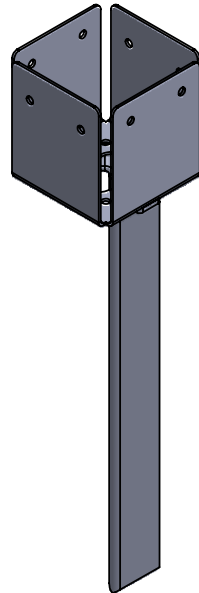

SPECIFICATIONS

Post holder

Models: EYE 100, PERI 100, TORRE 100 en SPINA 100

Weight: 2kg

timberlab

Timberlab B.V. - Harskamperweg 32 - 6731AB Otterlo
The Netherlands T +31 (0)318 943617 -

TITLE: PH03

FILE: Production drawing

REVISION A 17-1-2025

Drawn by:
DR





Checked by:
TvD

MATERIAL:
Kastanje

A4

Scale: 1:5

SHEET 1 OF 1

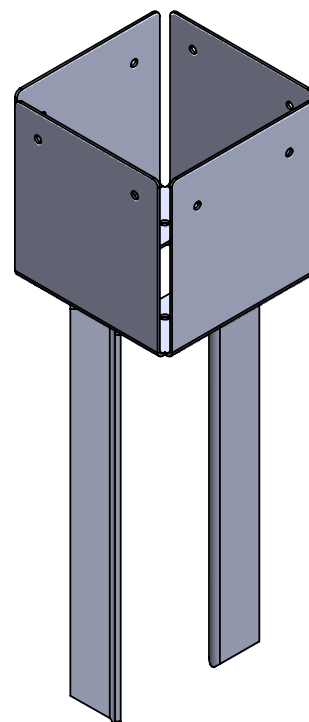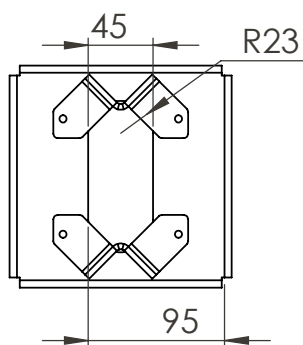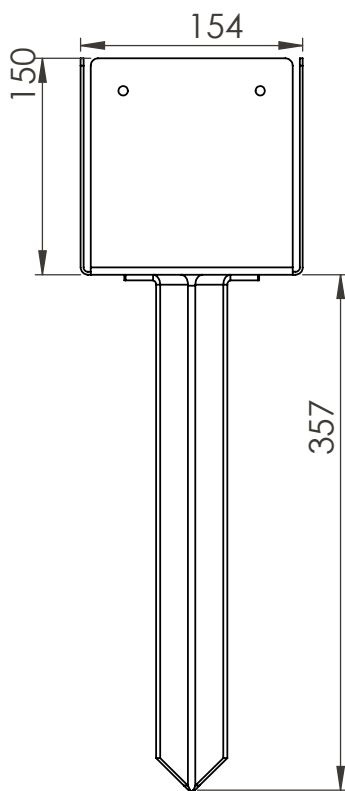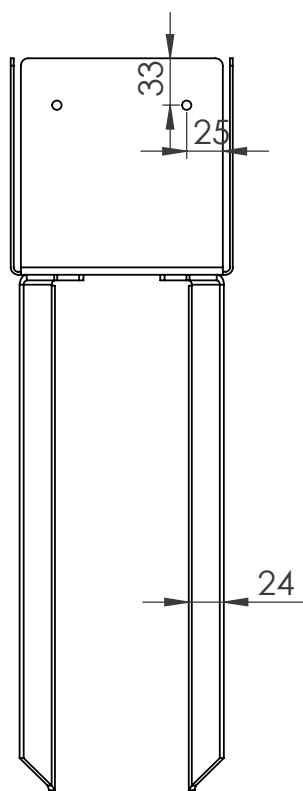

SPECIFICATIONS

Post holder

Models: EYE 150, PERI 150, TORRE 150, SPINA 150 en TORRE

Weight: 2 kg

timberlab

Timberlab B.V. - Harskamperweg 32 - 6731AB Otterlo
The Netherlands T +31(0)318 943617 -

TITLE: PH04

FILE: Production drawing

REVISION A 17-1-2025

Drawn by:

DR

Checked by:

TvD




MATERIAL:

Kastanje

A4

Scale: 1:5

SHEET 1 OF 1

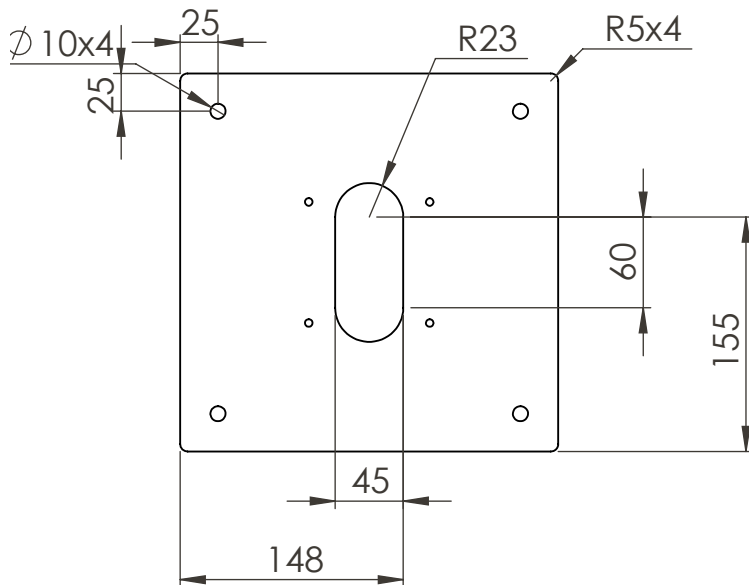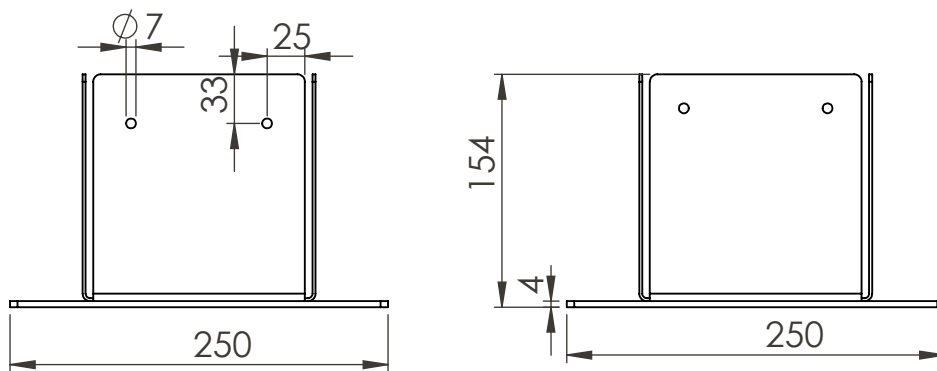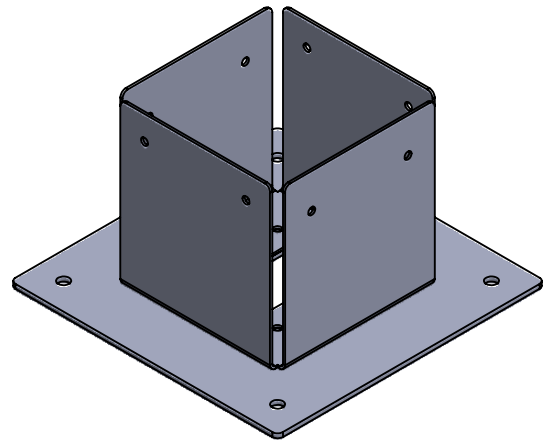

SPECIFICATIONS

Post holder

Models: EYE 150, PERI 150, SPINA 150, TORRE 150 en FARO

Weight: 4 kg

timberlab

Timberlab B.V. - Harskamperweg 32 - 6731AB Otterlo
The Netherlands T +31(0)318 943617 -

TITLE: PH05

FILE: Production drawing

REVISION A 17-1-2025

Drawn by:

DR





Checked by:

TvD

MATERIAL:

Kastanie

A4

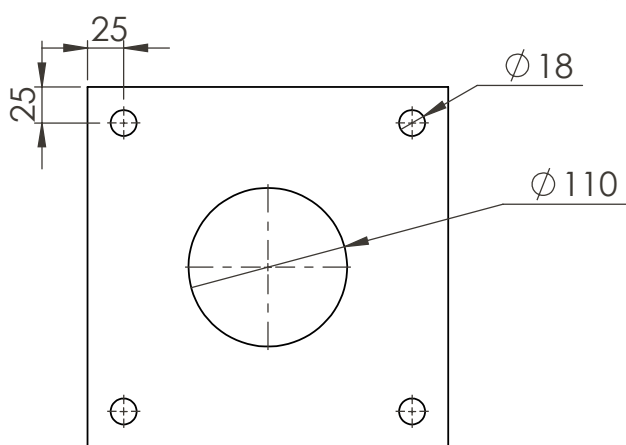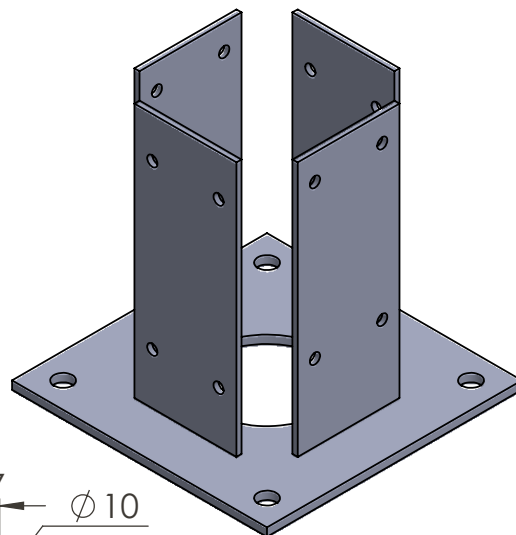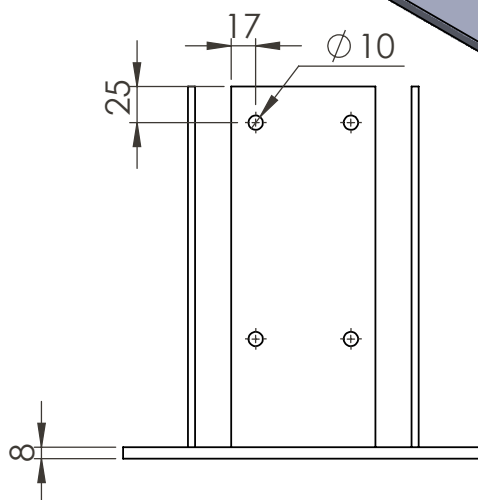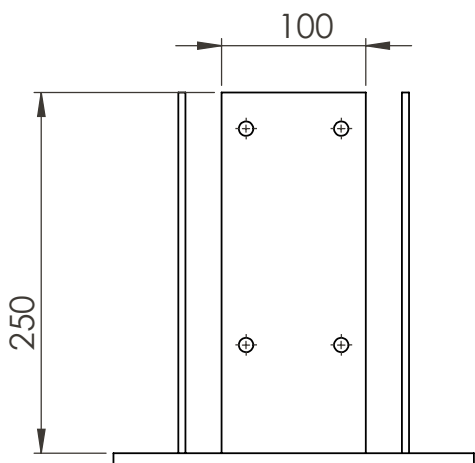

SPECIFICATIES

Post holder

Models: STRATO, STELLE, ANGELO, DARIO, and PILA

Weight: 7 kg

timberlab

Timberlab B.V. - Harskamperweg 32 - 6731AB Otterlo
The Netherlands T +31(0)318 943617 -

TITLE: PH07

FILE: Production drawing

REVISION A 17-1-2025

Drawn by:

DR





Checked by:

TvD

MATERIAL:

Kastanje

A4

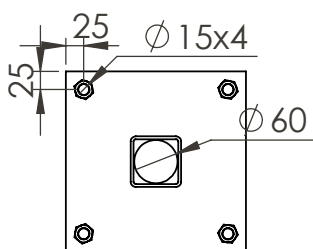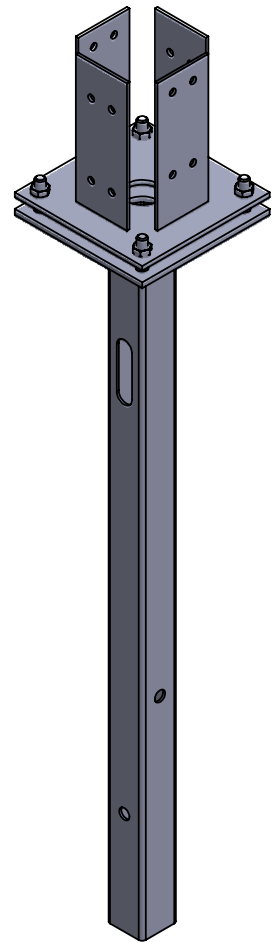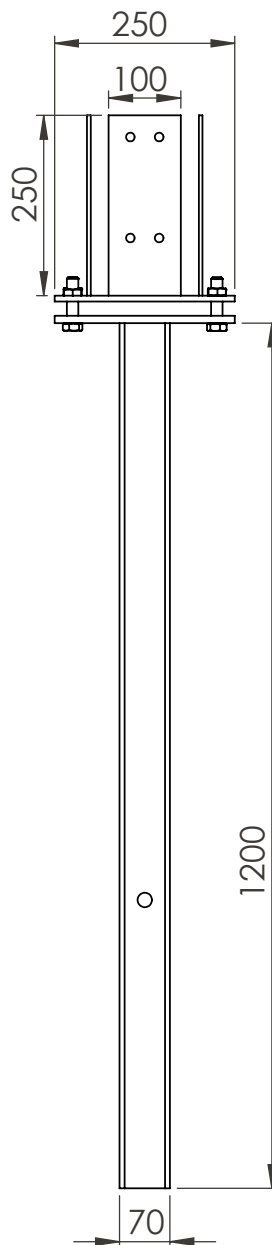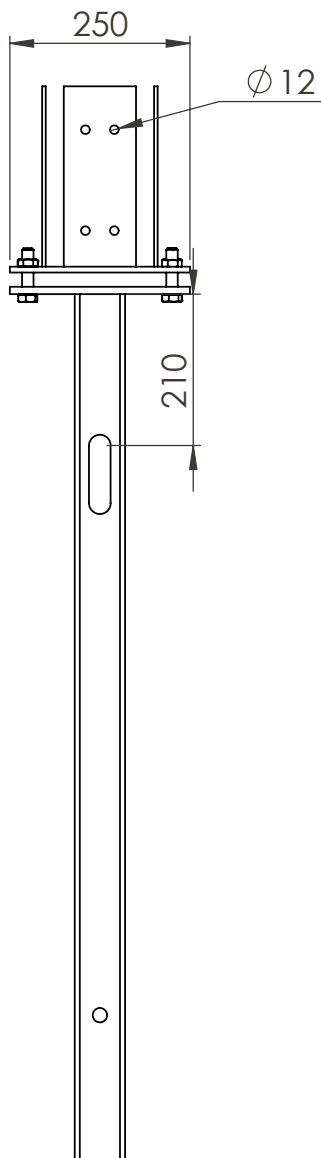

SPECIFICATIONS

Post holder

Models: STRATO, STELLE, ANGELO, DARIO, and PILA

Weight: 20 kg

timberlab

Timberlab B.V. - Harskamperweg 32 - 6731AB Otterlo
The Netherlands T +31 (0)318 943617 -

TITLE: PH08			
FILE: Production drawing		REVISION A 20-1-2025	
Drawn by: DR	Checked by: TvD	MATERIAL: Kastanje	A4
Scale: 1:10		SHEET 1 OF 1	

DOWNLOADS

For more information, visit <https://timberlab-solutions.com/> where you can find a manual, 3Ds file, and create a lighting plan with our Light Calculator.

The documents that can be downloaded are:

- Datasheet Smart Motion Sensor
- Manual

Other links are:

- Specification text
- Lighting plan

Disclaimer

The information presented in this datasheet is carefully compiled by Timberlab with care and attention. Nevertheless, it is possible that the information published in the datasheet is incomplete and/or incorrect.

